



THIS DRAWING IS PROPERTY OF SP AND MAY NOT BE REPRODUCED OR RELEASED TO THIRD PARTIES WITHOUT WRITTEN AUTHORIZATION

# PROFILE

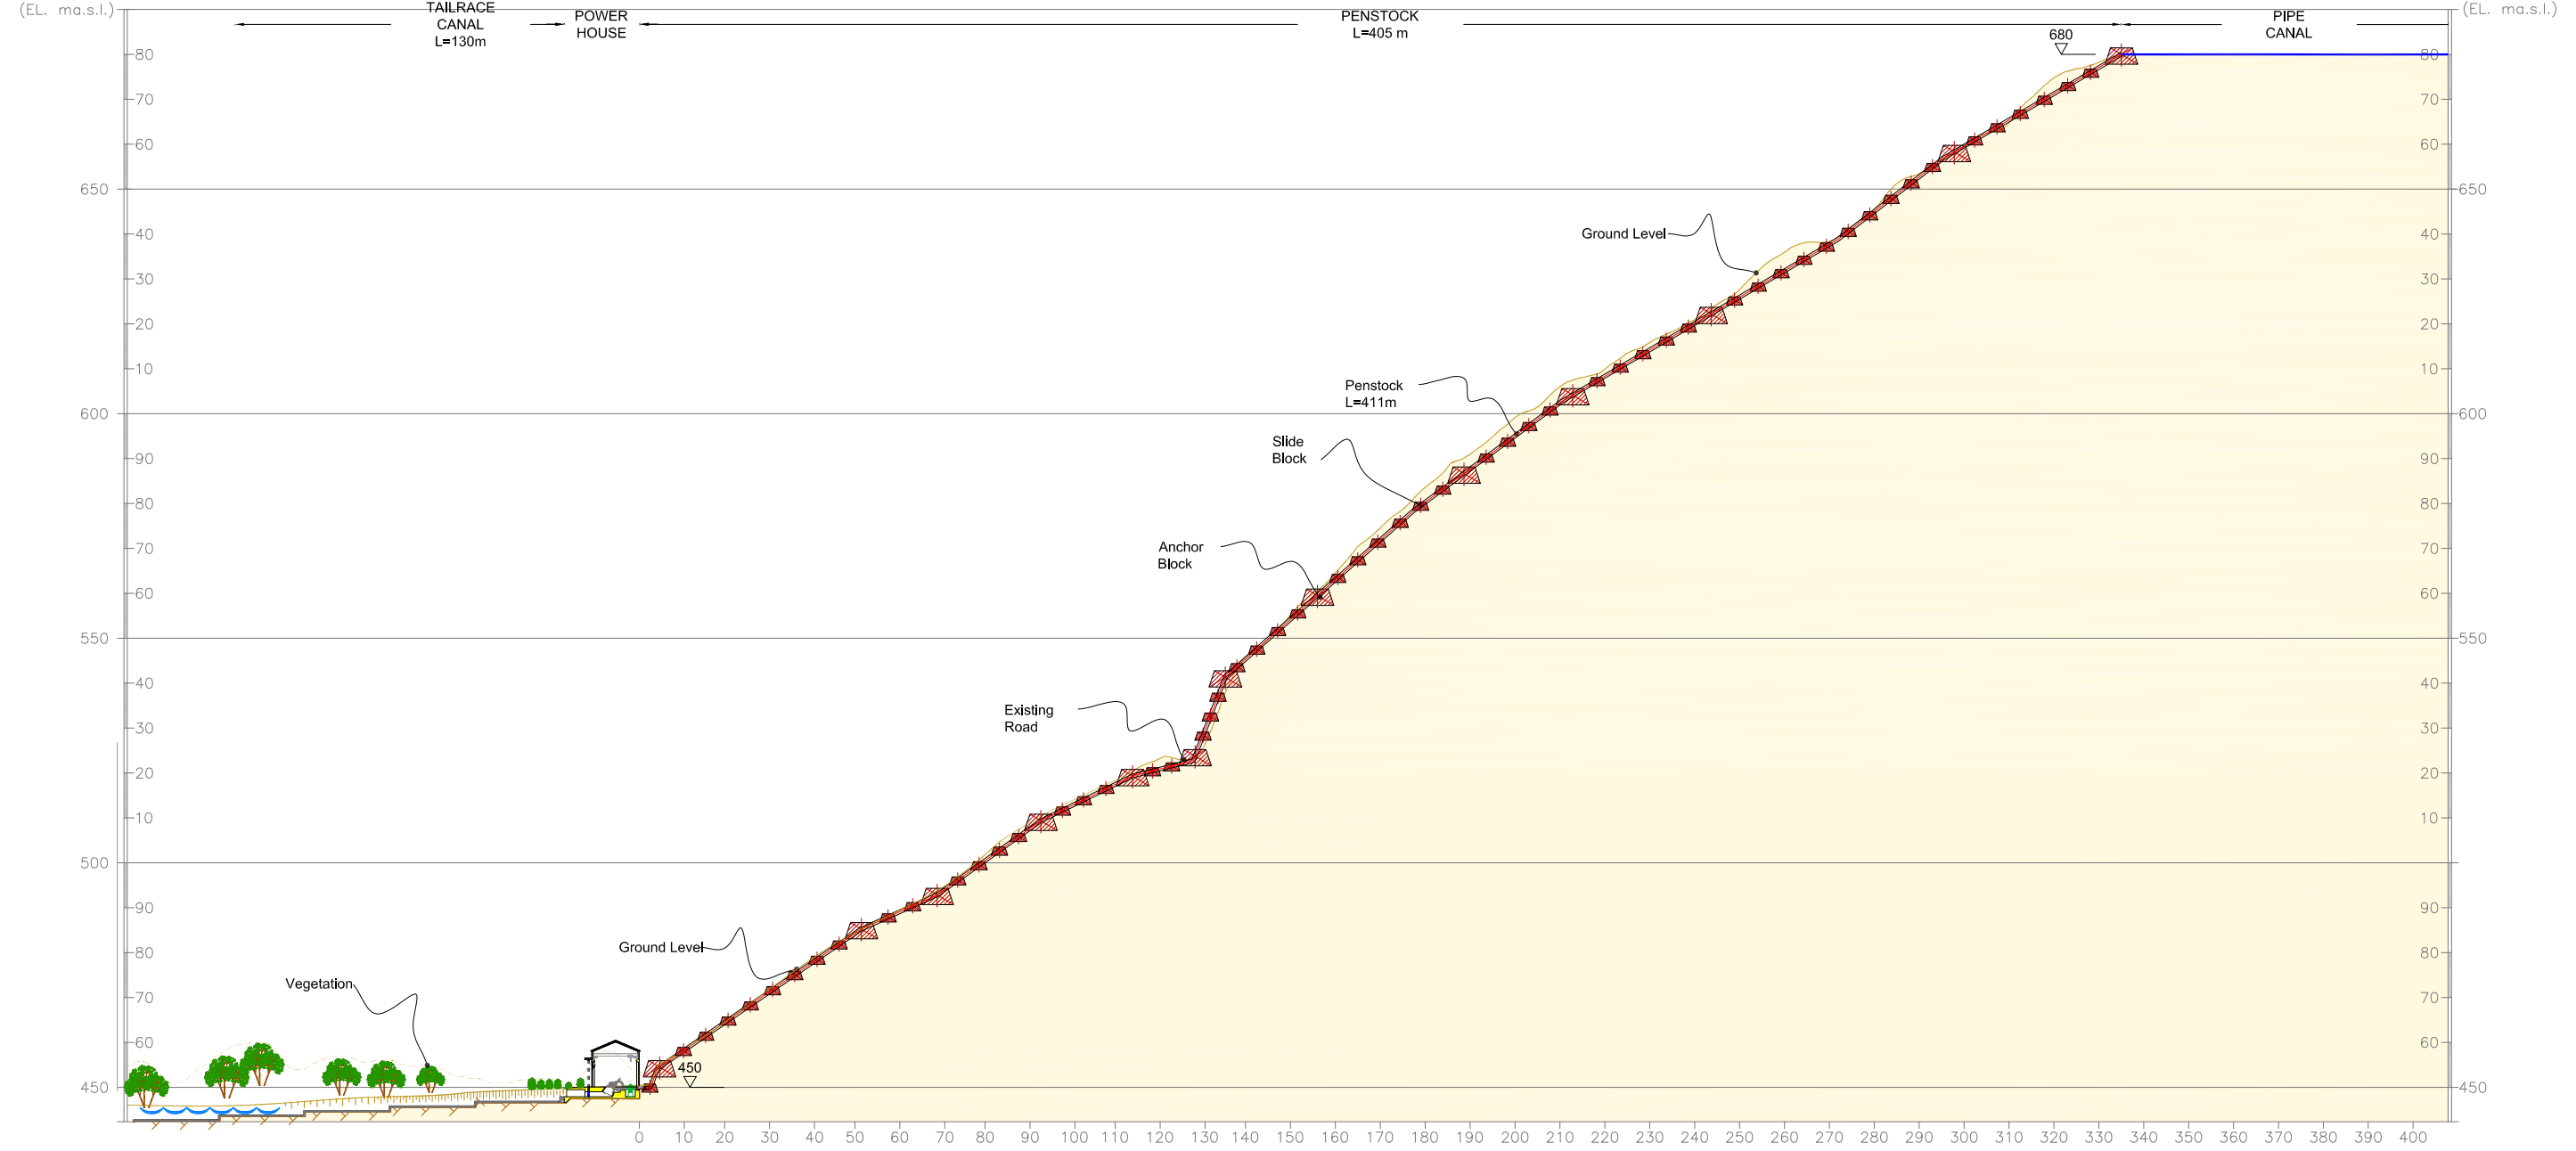

Station	Ground El (m.a.s.l.)	Penstock Axis El (m.a.s.l.)
0	450.0	450.0
10	454.5	454.5
20	458.2	458.2
30	461.6	461.6
40	465.0	465.0
50	468.3	468.3
60	471.7	471.7
70	475.1	475.1
80	478.5	478.5
90	481.9	481.9
100	485.2	485.2
110	488.2	488.2
120	490.4	490.4
130	492.9	492.9
140	496.1	496.1
150	499.5	499.5
160	502.8	502.8
170	505.8	505.8
180	508.4	508.4
190	511.7	511.7
200	514.0	514.0
210	516.4	516.4
220	519.3	519.3
230	520.5	520.5
240	521.5	521.5
250	523.5	523.5
260	525.8	525.8
270	528.2	528.2
280	531.3	531.3
290	534.3	534.3
300	537.7	537.7
310	541.1	541.1
320	543.6	543.6
330	547.8	547.8
340	551.9	551.9
350	555.6	555.6
360	559.5	559.5
370	563.5	563.5
380	567.4	567.4
390	571.4	571.4
400	575.8	575.8
410	579.6	579.6
420	583.2	583.2
430	586.7	586.7
440	590.2	590.2
450	593.6	593.6
460	597.7	597.7
470	600.6	600.6
480	604.1	604.1
490	607.5	607.5
500	610.3	610.3
510	613.3	613.3
520	617.7	617.7
530	620.3	620.3
540	622.2	622.2
550	625.3	625.3
560	628.4	628.4
570	631.3	631.3
580	634.3	634.3
590	637.3	637.3
600	640.6	640.6
610	644.3	644.3
620	647.9	647.9
630	650.0	650.0
640	655.0	655.0
650	658.0	658.0
660	661.3	661.3
670	663.8	663.8
680	666.8	666.8
690	669.9	669.9
700	673.0	673.0
710	676.3	676.3
720	676.0	676.0
730	677.6	677.6
740	680.0	680.0

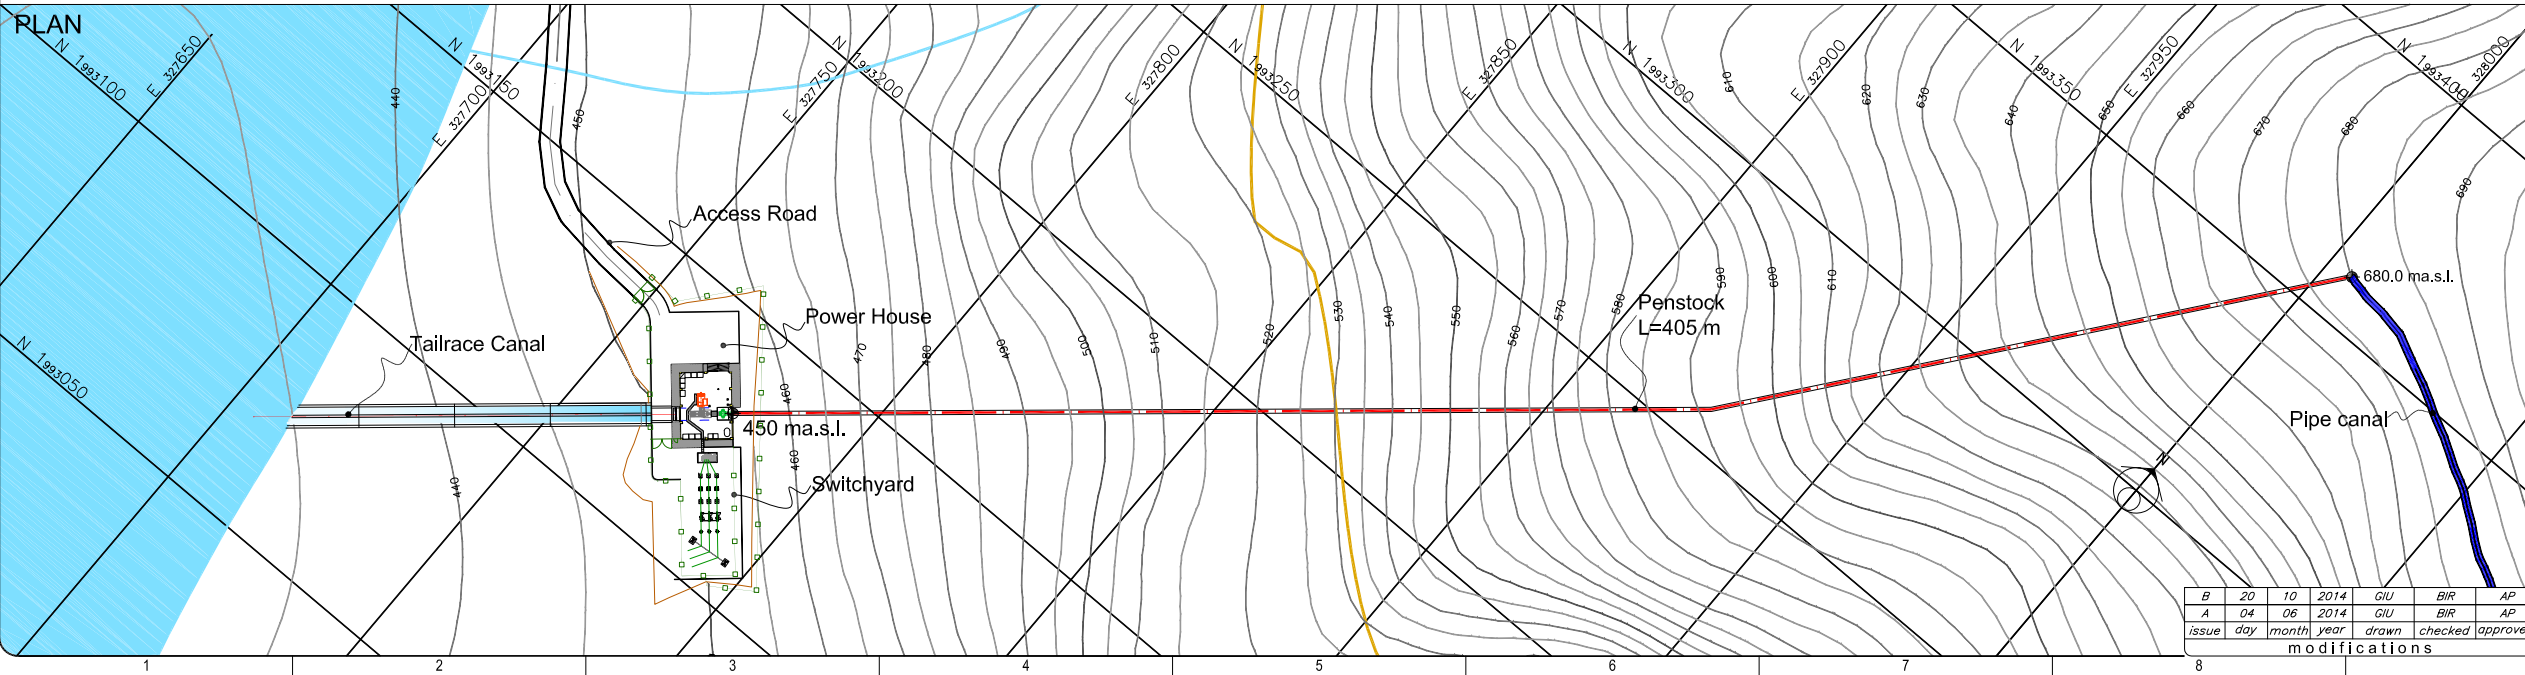

**NOTES**

- Topography data plan based on the NLA 12'500 TOPOMAPS INDEX 105B, 105D, 115A, 115C. PROJECTION: UTM\_ZONE 18N DATUM: WGS 1984 Countours vertical: METERS
- Topography data profile based on the PLEIADES. Acquisition: 2014. Image Resolution: 50 cm/pixel (B&W) Restitution: Photogrammetric Technique Map Datum: PROJECTION: UTM\_ZONE 18N DATUM: WGS 1984 ELEVATION: EGM 2008

Scale: 1:1500 (A3 size)

beneficiary: **Government of Jamaica**

project: **Ministry of Science, Technology, Energy and Mining**

designer: **JAM FIVE hpp**

design: **SP studio ing. g. pietrangeli consulting engineers**

title: **Phase 2 - Feasibility**

4 - NEGRO RIVER  
270 = PENSTOCK

**Plan and Profile**

B	20	10	2014	GIU	BIR	AP
A	04	06	2014	GIU	BIR	AP
issue	day	month	year	drawn	checked	approved
modifications						

270 | PSK | DSP | 4 | 0 | 1 | B | 20 Oct 2014

section - kind works - type - office - proj - serial n° - rev. - date